


ACAD Ref: 24.0s (LMS Tech)
 Filename: R:\Freese & Nichols\2022 - San Marcos Highway 80 Lift Station\Design\100%\Drawings\E-2 Site Plan.dwg
 Last Saved: 4/10/2025 10:27 PM Saved By: BDaleon

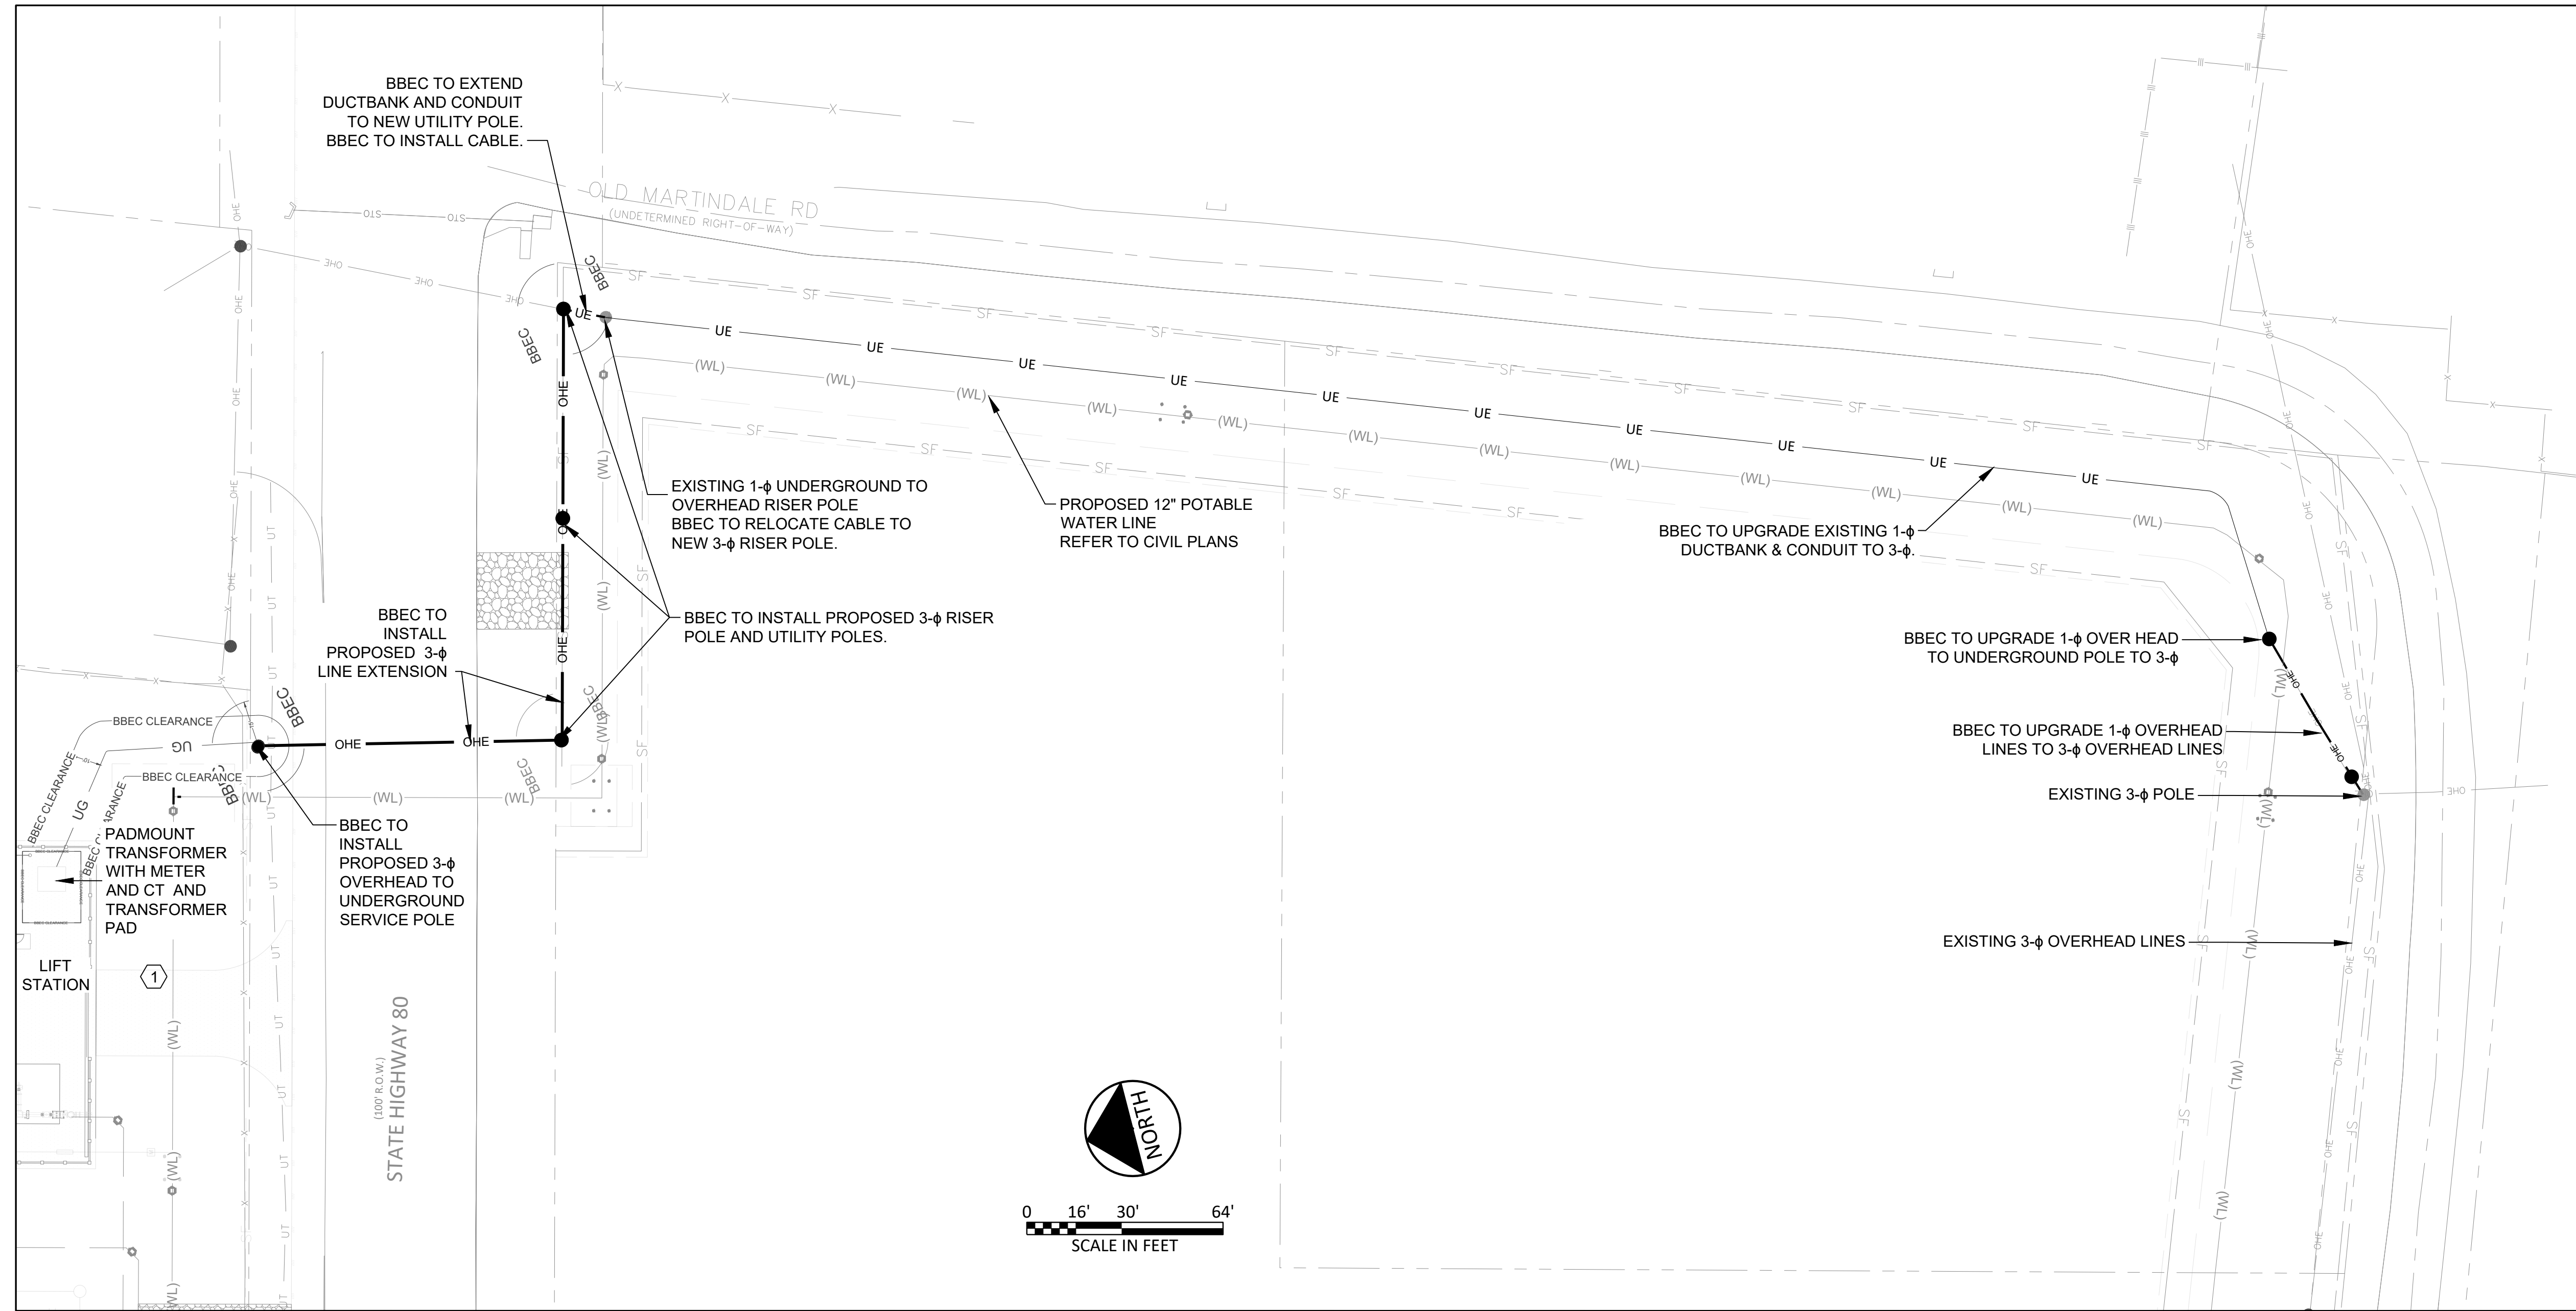

A BBEC PRIMARY POWER DISTRIBUTION (THIS SHEET IS FOR BBEC USE ONLY)
 SCALE: AS SHOWN

LEGEND	
— UE —	BBEC UNDERGROUND ELECTRIC
— OHE —	BBEC OVERHEAD LINES

GENERAL NOTES



- ALL ELECTRICAL MATERIALS AND INSTALLATION SHALL COMPLY WITH THE NATIONAL ELECTRICAL CODE; LOCAL AND STATE ORDINANCES, CODES AND REGULATIONS; AND, THE ELECTRIC UTILITY CRITERIA FOR INSTALLATION OF ELECTRICAL SERVICE.
- THE CONTRACTOR SHALL BE RESPONSIBLE FOR OBTAINING ALL ELECTRICAL PERMITS, INSPECTIONS ETC. UNTIL THE PROJECT IS ACCEPTED BY THE OWNER. CONTRACTOR SHALL PAY ALL FEES INVOLVED IN OBTAINING PERMITS AND INSPECTIONS AND SHALL INCLUDE THE COST OF THE SAME IN HIS BID.
- CONDUITS SHALL BE INSTALLED A MINIMUM OF 24" BELOW FINISHED GRADE ELEVATION. STUBUPS SHALL BE MADE WITH LONG RADIUS PVC COATED RIGID ELBOWS.

NOTES:

- CONTRACTOR SHALL OBSERVE NEC WORKING SPACE REQUIREMENTS WHEN LOCATING EQUIPMENT.
- IF LOCATION OF ELECTRIC PAD MOUNT TRANSFORMER CHANGES DURING CONSTRUCTION PHASE, CONTRACTOR SHALL NOTIFY ENGINEER IMMEDIATELY FOR APPROVAL.
- CONTRACTOR TO COORDINATE AND FOLLOW BBEC STANDARDS SHOWN IN APPENDIX FOR UNDERGROUND DUCTBANK LINE EXTENSION TO PAD MOUNT TRANSFORMER AND FOR THE INSTALLATION OF THE PAD MOUNT TRANSFORMER SLAB, STUB UPS AND SERVICE RACK.
- CONTRACTOR TO REPAIR AND REPAVE SIDE WALK, CURB AND ROADWAY THAT WAS DAMAGED DURING DUCTBANK INSTALLATION FOR THE SERVICE LINE EXTENSION TO THE SITE.

KEY NOTES

- REFER TO SHEET E-2 GENERAL NOTE 5 FOR WORK DONE NORTH OF THE RISER POLE

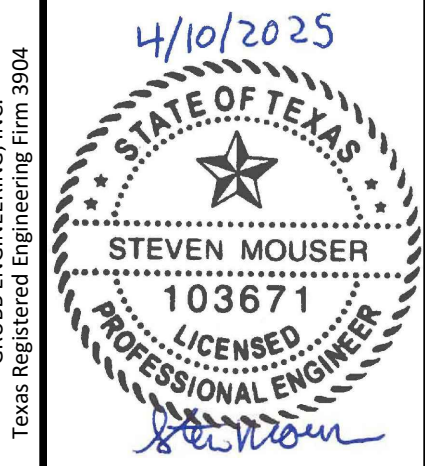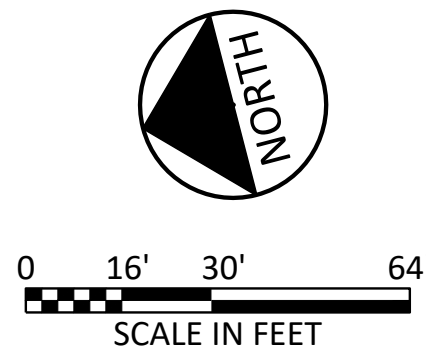

GRUBB ENGINEERING, INC.
 ELECTRICAL POWER SYSTEMS
 DESIGN AND TESTING
 TBPE FIRM REGISTRATION NO. 3904
 2727 NORTH SAINT MARY'S ST.
 SAN ANTONIO, TX 78212
 P 210.658.7250 F 210.658.9805
 WWW.GRUBBENGINEERING.COM

CITY OF SAN MARCOS
HIGHWAY 80 UTILITY PROJECT
 ELECTRICAL
SITE PLAN FOR BBEC USE ONLY

NO.	ISSUE	DATE	BY	FILE NAME
0	VERIFY SCALE			Bar is one inch on original drawing. If not one inch on this sheet, adjust scale.
1				

F&N JOB NO. SAM21551
 DATE 04/10/2025
 DESIGNED BD, SM
 DRAWN BD, SG
 REVISED
 CHECKED SM
 FILE NAME
 SHEET E-2A
 SEQ.